

ISSUED FOR SPA



DO NOT SCALE DRAWINGS

1.	2026/02/20	ISSUED FOR SPA	M.S.B.
NO.	DATE	DESCRIPTION	BY

MARK VOID ALL PRINTS DATED PREVIOUS TO FINAL DATE ABOVE

REVISIONS

ALL DRAWINGS, SPECIFICATIONS AND RELATED DOCUMENTS ARE THE COPYRIGHT PROPERTY OF THE ENGINEER AND MUST BE RETURNED UPON REQUEST. ANY REPRODUCTION OF DRAWINGS, SPECIFICATIONS AND RELATED DOCUMENTS IS PROHIBITED WITHOUT THE ENGINEER'S CONSENT. THE CONTRACTOR SHALL CHECK AND VERIFY EVERYTHING AND REPORT ALL ERRORS AND OMISSIONS TO THE ENGINEER

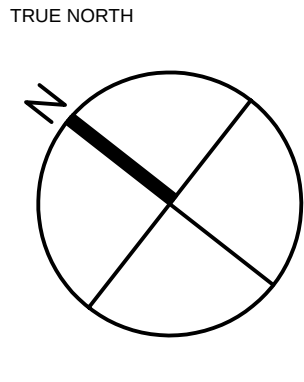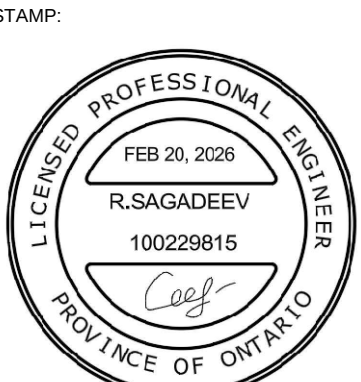


PROJECT NAME:
PROPOSED WAREHOUSE/STORAGE DEVELOPMENT

PROJECT ADDRESS:
8995 BOSTON CHURCH RD, MILTON, ON

SITE PLAN- LIGHTING

DRAWN BY:	R.S
CHECKED BY:	M.S.B.
DATE:	FEB, 2026
PROJECT NO:	2026-011
SCALE:	1:700
DRAWING NO:	E-100

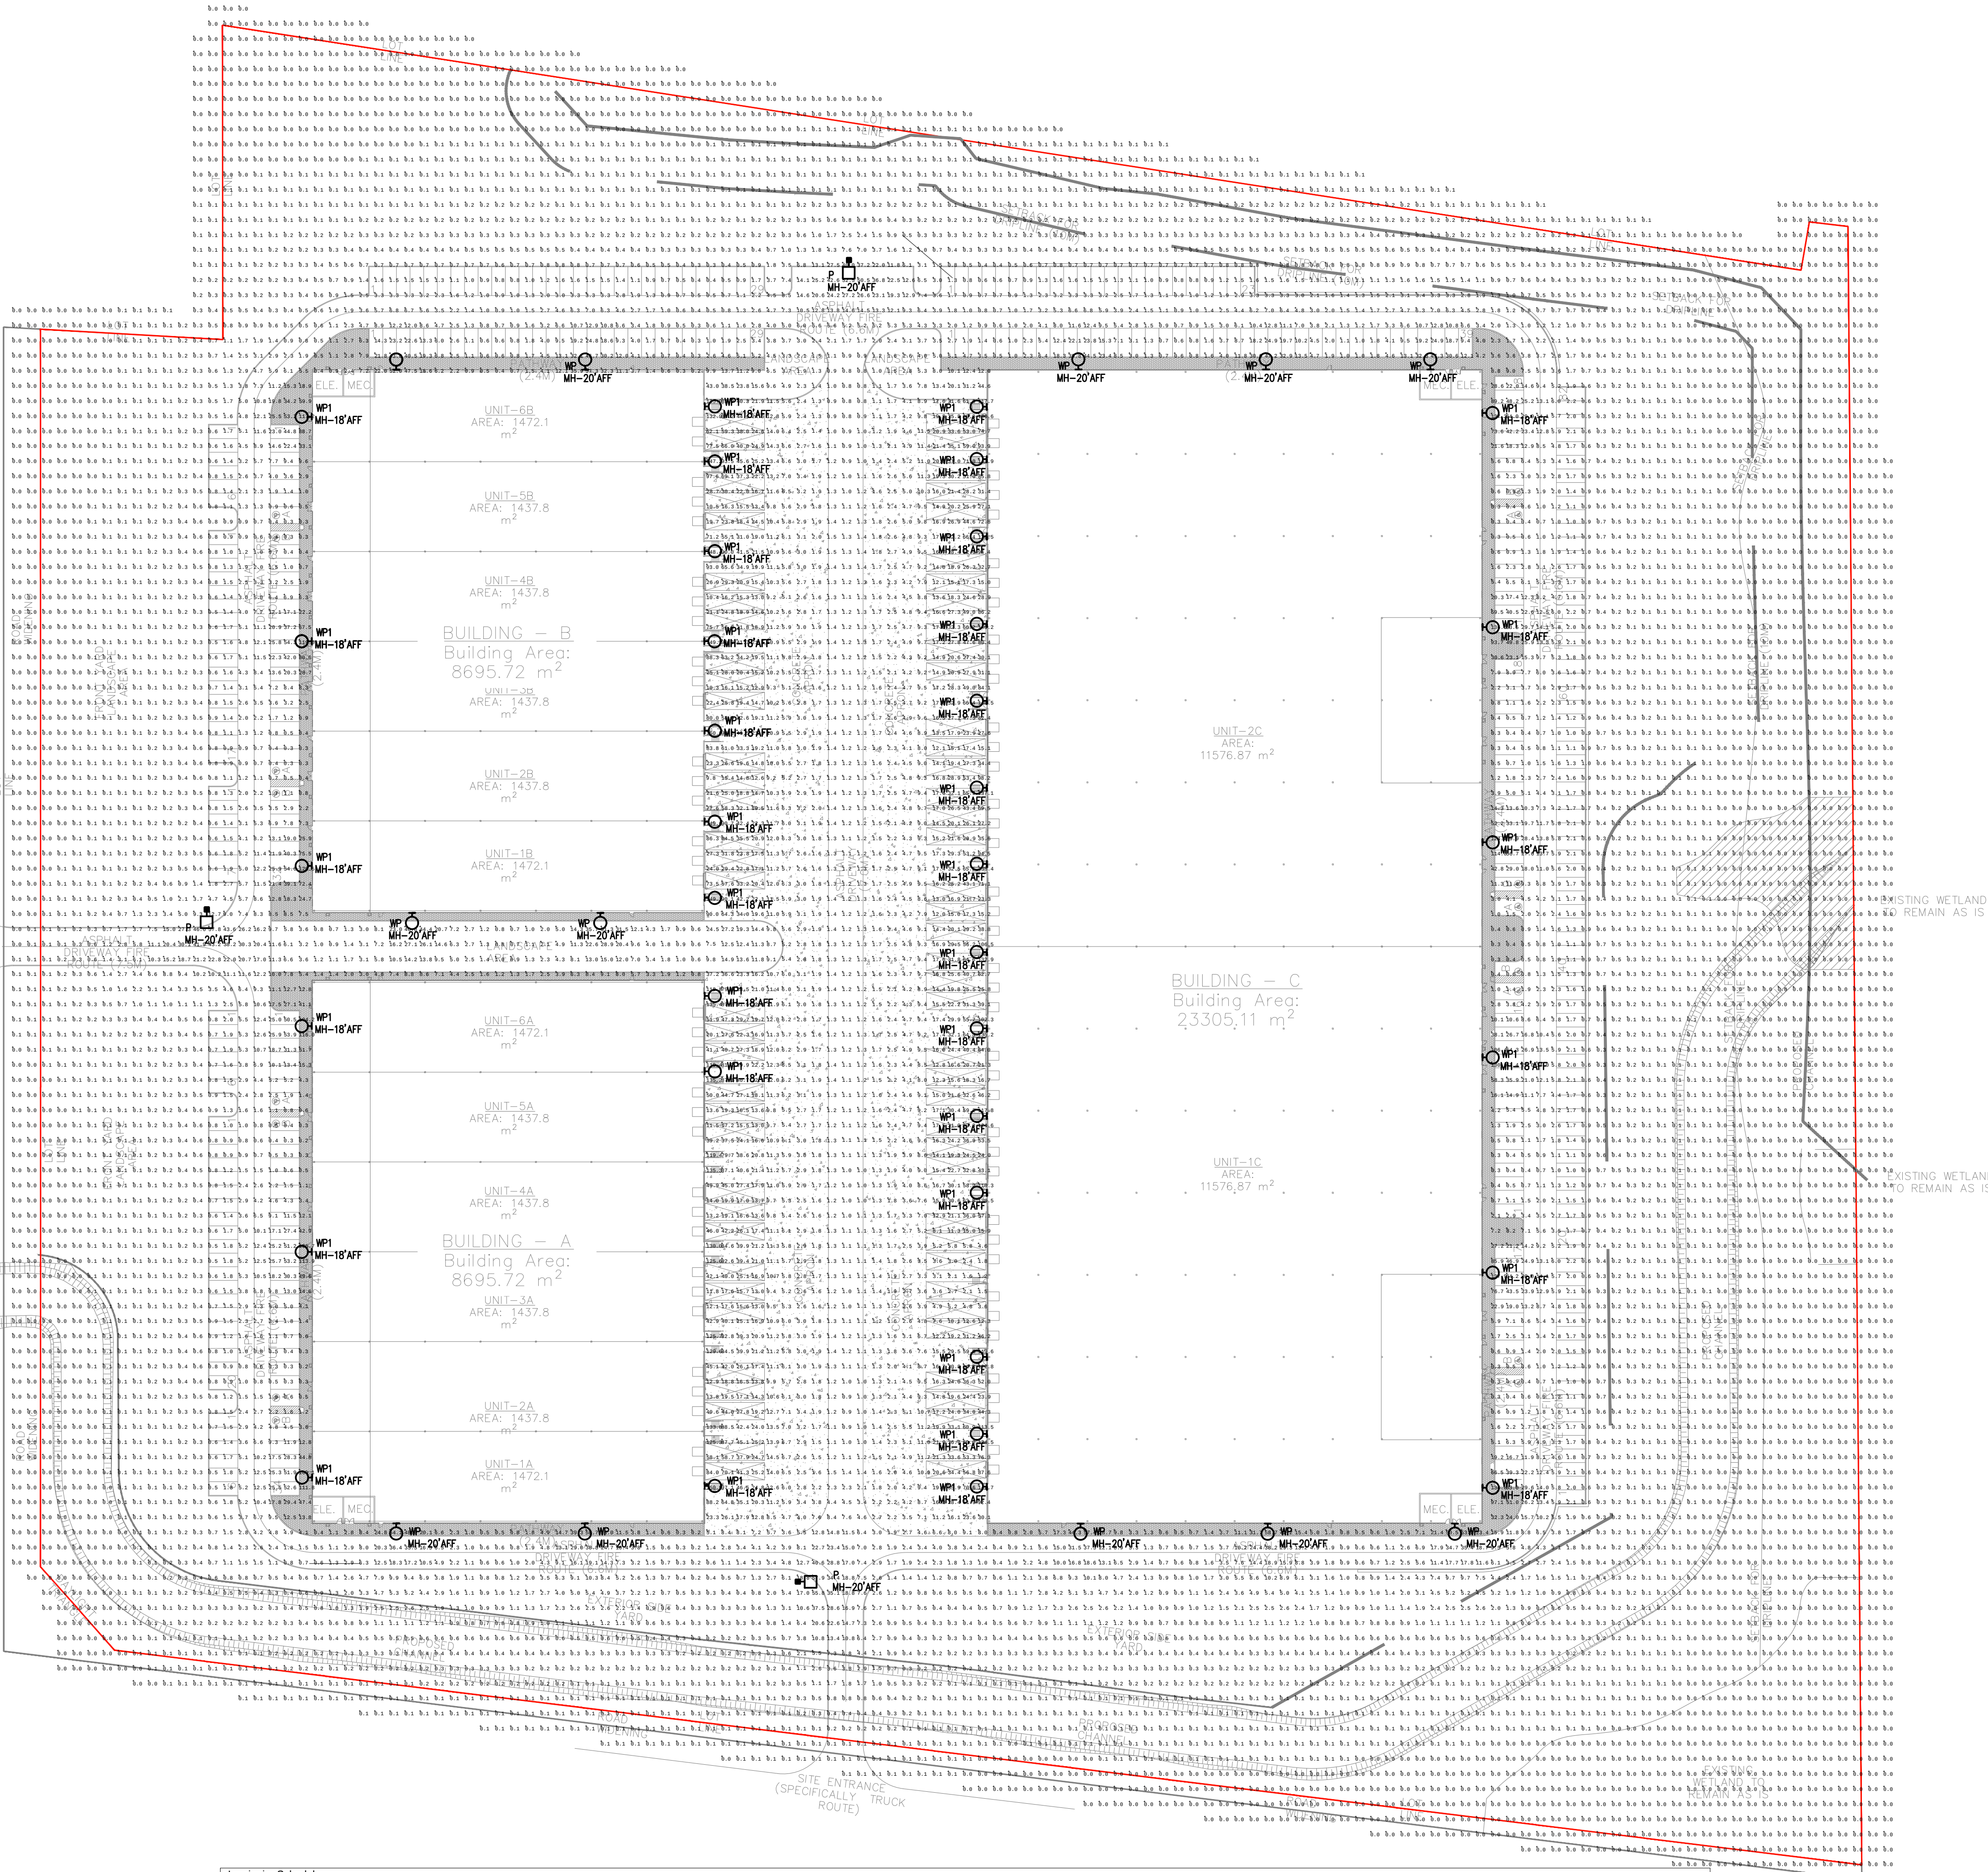

Luminaire Schedule									
Symbol	Qty	Label	Description	Lum. Lumens	Lum. Watts	LLF	Filename	Mounting Height	
○	40	WP1	WFC-PS100A3-Q-3C-100W-30K-68608	12300	100	0.900	WFC-PS100A3-Q-3C-100W-30K-68608.ies	18	
■	3	P	ALK-LS4C4-XX-30K-69422	9167	115	0.900	ALK-LS4C4-XX-30K-69422.IES	20	
○	12	WP	WFC-PS60A4-Q-3C-60W-30K	7416	60	0.900	WFC-PS60A4-Q-3C-60W-30K.IES	20	
Calculation Summary									
Label	CalcType	Units	Avg	Max	Min	Avg/Min	Max/Min		
Site	Illuminance	Lux	5.06	150.5	0.0	N.A.	N.A.		